


MCC B1-P1/P2  
2X3/C-4/0, 1KV, TECK.

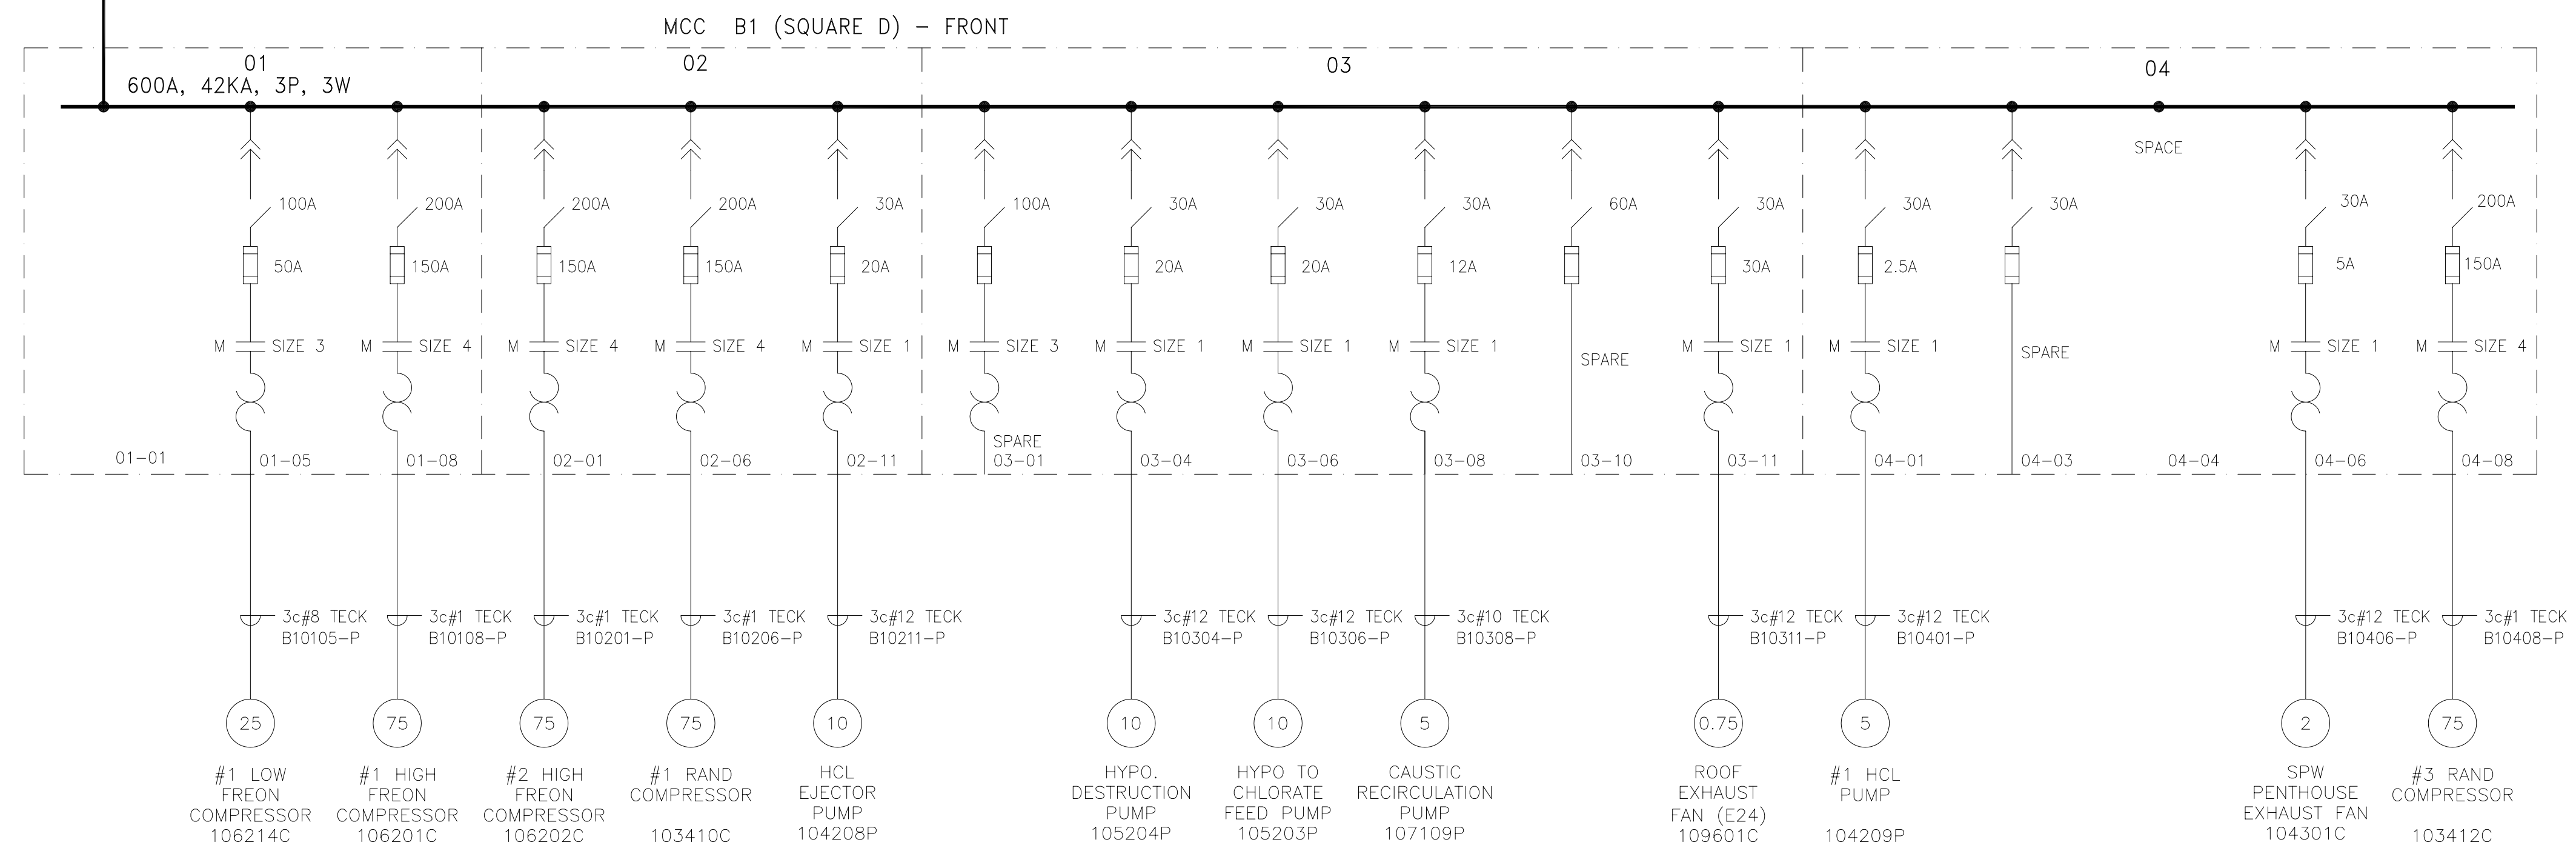

No.	DATE	BY	DESCRIPTION	CHKD.
0	19 OCT 2000	RJA	ISSUED FOR CONSTRUCTION	
A	20 SEPT 2000	JMH	ISSUED FOR TENDER	

REVISIONS	

DWG. No. TITLE

REFERENCE DRAWINGS

PRELIMINARY - NOT FOR CONSTRUCTION

APPROVED FOR CONSTRUCTION

SUPERSEDES ALL PREVIOUS ISSUES

BY	DATE
DESIGNED	DATE
JJB	JMH
CHECKED	DATE
JJB	24 AUG, 2000
DESIGN	DRAFTING
	SCALE
	NTS
PROJECT MANAGER	SPECIFICATION No.
JJB	10011-IS-02
PROJECT TECHNICIAN	
RJA	



MCC UPGRADE PROJECT

SINGLE LINE DIAGRAM  
MCC B1  
PHASE 1

JOB No. 10011 CONSULTANT DWG. No.

DWG. No. 10011-002 SHT. 1